


DOOR SCHEDULE

DOOR NO.	LOCATION	QTY	SWING	LEAF	ELEV 'N TYPE	CONST.	DOOR			MATL	GLAZING (mm)	FRAME	UNDERCUT	FINISH	NOTES
							WIDTH (mm)	HEIGHT (mm)	THICK (mm)						
WD01	MAIN DOOR	1	RH	1	A	-	1300	2400	50	WD	-	WD	-	EXISTING DOOR TO BE CLADDED WITH WHITE HIGH GLOSS LAMINATE. DESIGN TO BE VERIFIED	VERIFY DIMENSIONS ON SITE.
WD02	POWDER RM.	1	LH	1	B	HC	900	2300	50	WD	-	WD	6	WHITE HIGH GLOSS LACQUER	DOOR NEEDS TO BE FLUSHED TO THE WALL PANELS IN THE HALLWAY. DETAIL TO FOLLOW.
WD03	KITCHEN 1	1	DS	1	C	HC	900	2300	50	WD	-	WD	6	WHITE HIGH GLOSS LACQUER	WITH VISION PANEL AND PUSH PLATE DETAIL
WD04	KITCHEN 2	1	DS	1	C	HC	900	2400	50	WD	-	WD	6	WHITE HIGH GLOSS LACQUER	WITH VISION PANEL AND PUSH PLATE DETAIL
WD05	MAID'S ROOM	1	LH	1	D	HC	800	2400	50	WD	-	WD	6	WHITE HIGH GLOSS LACQUER	
WD06	MAID'S T&B	1	RHR	2	E	HC	600	2400	50	WD	-	WD	6	WHITE HIGH GLOSS LACQUER	
WD07	BEDROOM 1, DRESSING ROOM, MASTER BEDROOM	3	LH/RH	1	D	HC	900	2300	50	WD	-	WD	6	WHITE HIGH GLOSS LACQUER	
WD08	T&B1	1	S	1	F	HC	800	2300	50	WD	-	WD	6	WHITE HIGH GLOSS LACQUER	
WD09	T&B2	1	RH	1	D	HC	800	2300	50	WD	-	WD	6	WHITE HIGH GLOSS LACQUER	
WD10	MASTER T&B	1	LH	1	D	HC	900	2300	50	WD	-	WD	6	WHITE HIGH GLOSS LACQUER	
WD11	FAMILY AREA	1	S	1	G	HC	1500	2300	50	WD	-	WD	6	WHITE HIGH GLOSS LACQUER	
WD12	MASTER TB	1	RH	1	H	-	EXISTING	EXISTING	50	EXISTING	-	EXISTING	EXISTING	EXISTING DOOR TO BE CLADDED WITH BACKLIT MIRROR.	

ABBREVIATIONS:

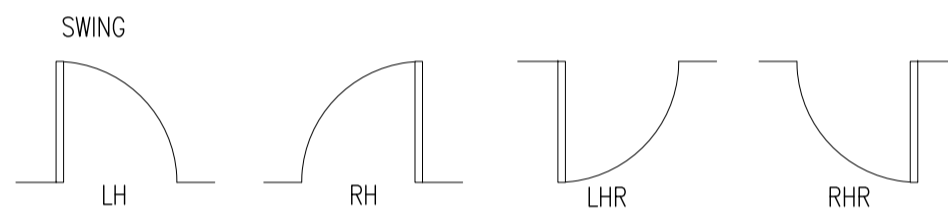

S - SLIDING
F - FIXED
DS - DOUBLE SWING
RU - ROLL UP
P - PIVOT

CONSTRUCTION:

HC - HOLLOW CORE
SC - SOLID CORE
SP - SPECIAL DOOR
SOLID - SOLID PANELS

MATERIAL:

ALUM. - ALUMINUM
CONC. - CONCRETE
G - GLASS
WD - WOOD
STL - STEEL
PVC - PLASTIC

GENERAL NOTES FOR DOORS:

1. DIMENSION SHOWN IN DRAWINGS INDICATE "FACE TO FACE" OF EFFECTIVE OPENING OF DOORS AND SHALL BE MEASURED AT THE SITE PRIOR TO START OF FABRICATION.
2. WEATHER SEALING STRIPS SHALL BE ATTACHED TO EXTERIOR DOORS.
3. GENERAL HARDWARE SETS SHALL BE PROVIDED BY MANUFACTURER. REFER TO SPECIFICATIONS FOR HARDWARE SCHEDULE.

PLAN	ELEVATION	FFL	TYPE	LOCATION	DOOR TAG
EXISTING DOOR TO BE CLADDED WITH WHITE HIGH GLOSS LAMINATE.			A	GF MAIN DOOR	WD01
			B	POWDER RM.	WD02
			C	KITCHEN 1, KITCHEN 2	WD03, WD04
			D	MAID'S RM.	WD05
			D	BEDROOM 1, DRESSING ROOM, MASTER BR.	WD07
			D	T&B2	WD09
			D	MASTER T&B	WD10
			E	MAID'S T&B	WD06
			F	T&B1	WD08
			G	FAMILY AREA	WD11

- POWER AND AUXILIARY**
- DUPLX UNIVERSAL OUTLET
 - WEATHERPROOF UNIVERSAL OUTLET
 - REFRIGERATOR OUTLET
 - OVEN OUTLET
 - RANGE HOOD OUTLET
 - WATER HEATER OUTLET
 - FLOOR DRAIN
 - CATV OUTLET
 - TELEPHONE OUTLET
 - FLOOR OUTLET: DUPLX
 - EXHAUST FAN
 - EXHAUST AIR
 - FRESH AIR DUCT OUTLET
 - FCU (WALL MOUNTED)
 - LINEAR DIFFUSER (CEILING MOUNTED)
 - SHOWER DRAIN
 - FLOOR CLEAN OUT
 - PANEL BOARD
 - GROMET-OUTLETS

- LIGHTING SYMBOLS**
- LED DOWNLIGHT
 - MOISTURE RESISTANT LED DOWNLIGHT
 - LED UP LIGHT
 - SPECIAL LIGHT: CHANDELER, PENDANT, LED WALL SCONCE
 - WALL MOUNTED LIGHT (UP/DOWN)
 - TS LED LIGHT
 - LED STRIP LIGHT
 - EMERGENCY LIGHT
 - CONCEALED PENDENT FIRE SPRINKLER
 - CONCEALED SIDE-THROW (HORIZONTAL) FIRE SPRINKLER
 - SMOKE DETECTOR
 - FIRE EXTINGUISHER
 - SMOKE DETECTOR
 - EMERGENCY LIGHT
 - MULTILINE
 - SWITCH - EXISTING
 - SWITCH - NEW

- EXISTING LIGHTING, POWER, AND AUXILIARY**
- RECESSED MOUNTED PINLIGHT
 - INDUSTRIAL TYPE FLUORESCENT LIGHT
 - FLUORESCENT LIGHT CEILING FIXTURES
 - RECESSED MOUNTED PINLIGHT
 - SURFACED MOUNTED PINLIGHT
 - PORCELAIN RECEPTACLE OUTLET
 - SMOKE DETECTOR
 - HEAT DETECTOR
 - SPRINKLER HEAD (PENDENT TYPE)
 - KITCHEN EXHAUST FAN
 - FAN COIL UNIT
 - SPRINKLER HEAD (SIDE THROW TYPE)
 - SPRINKLER HEAD (DOUBLE)
 - FIRE OUTBREAK ROOM INDICATOR
 - TOILET EXHAUST FAN

- SINGLE WALL CONVENIENCE OUTLET, 1P, 20A, 250V, PARALLEL SLOTS, GROUNDING TYPE
- REF - REFRIGERATOR OUTLET
- RH - RANGEHOOD OUTLET
- SE - SINK ERATOR OUTLET / SWITCH ERATOR
- SPECIAL PURPOSE OUTLET, 1P, 20A, 250V, GROUNDING TYPE OUTLET FOR 1.4KVA WASHING MACHINE
- WH - SPECIAL PURPOSE OUTLET, 1P, 40A, 250V, GROUNDING TYPE OUTLET FOR 60W WATER HEATER
- DW - SPECIAL PURPOSE OUTLET, 1P, 20A, 250V, GROUNDING TYPE OUTLET FOR 3KVA DISHWASHER
- HW - SINGLE WALL OUTLET, 1P, 20A, 250V, GROUNDING TYPE OUTLET FOR 1.2KVA MICROWAVE OVEN
- R - SPECIAL PURPOSE OUTLET, 1P, 50A, 250V, GROUNDING TYPE OUTLET FOR 8KVA ELECTRIC RANGE
- D - SPECIAL PURPOSE OUTLET, 1P, 30A, 250V, GROUNDING TYPE OUTLET FOR 3KVA DRYER

- DUPLX WALL CONVENIENCE OUTLET (COUNTER) 20A, 250V, PARALLEL SLOTS, GROUNDING TYPE
- DUPLX WALL CONVENIENCE OUTLET (COUNTER AT WEST AREA) 20A, 250V, PARALLEL SLOTS, GFO TYPE
- DUPLX WALL CONVENIENCE OUTLET 20A, 250V, PARALLEL SLOTS, GROUNDING TYPE
- NON - FUSED DISCONNECT SWITCH (NFDIS)
- UTILITY BOX PROVISION FOR ACCU
- TV OUTLET
- TELEPHONE OUTLET (ON A FIRE CAT 5E CABLE IN 25mm PVC)
- PULLBOX INSIDE TENANT, WALL MOUNTED WITH REQUIRED SPLITTERS 170 x 120 x 50mm (W x H x D)
- CATV PB

- RCP COLOR GUIDE**
- CFL+2800
 - CFL+2750
 - CFL+2500
 - CFL+2400
 - BEAM CFL+2300
 - CFL+2300
 - CFL+2200

- WALL FINISHES**
- WF-01 WHITE FLAT ACRYLIC WATER BASED LATEX PAINT ON EXISTING WALL
 - WF-02 WHITE FLAT ACRYLIC WATER BASED LATEX PAINT ON NEW WALL
 - WF-03 WALL PANEL SYSTEM BY SPACE2000 IN WHITE HIGH GLOSS FINISH
 - WF-04 "SELECTED" SALVATORI TILE (BY HOMESTUDIO)
 - WF-05 300X600MM 10MM THK HOMOGENOUS PORCELAIN TILES HONED FINISH R-10 SLIP RATING (BY HOMESTUDIO)
 - WF-06 VINYL FINISH ON EXISTING WALL
 - WF-07 EXISTING GLASS SHOWER ENCLOSURE
 - WF-08 1X3M ERGON TILE IN "LIMESTONE WHITE" (BY HOMESTUDIO)
 - WF-09 WALL PANEL SYSTEM BY SPACE2000 IN MATTE WARM GREY LACQUER

- CEILING FINISHES**
- CF-01 WHITE FLAT ACRYLIC WATER BASED LATEX PAINT ON EXISTING CEILING
 - CF-02 12MM THK GYPSUM BOARD IN WHITE FLAT ACRYLIC WATER BASED LATEX PAINT WITH LIGHT GA. STEEL FRAMING SPACED AT EVERY 400MM O.C.
 - CF-03 12MM THK MOISTURE RESISTANT GYPSUM BOARD IN FLAT FINISH ON TOP OF STEEL FRAMING SPACED AT EVERY 600MM O.C. B.W. (BY HOMESTUDIO)
 - FF-01 "SELECTED" SALVATORI TILE (BY HOMESTUDIO)
 - FF-02 "SELECTED" SALVATORI TILE (BY HOMESTUDIO)
 - FF-03 300X600MM 10MM THK HOMOGENOUS PORCELAIN TILES, R-12 SLIP RATING (BY HOMESTUDIO)

ARCHITECT JOR CALMA & PARTNERS architecture interior design furniture JOSE EDUARDO G. CALMA ARCHITECT	STRUCTURAL CONSULTANT	ELECTRICAL CONSULTANT	PLUMBING CONSULTANT	MECHANICAL CONSULTANT	OWNER PATRICK KANG	PROJECT TITLE KANG CONDOMINIUM UNIT 47-A, WEST TOWER AT ONE SERENDRA BONIFACIO GLOBAL CITY	Number Date By Description of Revisions Sheet Title	SHEET NO. A-700
ENGINEER	ENGINEER	ENGINEER	ENGINEER	ENGINEER			Scale: As Indicated Project Issue Date: Approved By: Drawn By: Designed By: Checked By:	

THESE DRAWINGS ACTING AS INSTRUMENTS OF SERVICE ARE THE PROPERTY OF ARCH. ED. G. CALMA AND AS SUCH MUST NOT BE USED OR REPRODUCED WITHOUT SPECIFIC PERMISSION. (RA1006, ART. A, SEC. 33)