



**NOTE:**


- PROVIDE 19MMX19MM SHADOW GAP BETWEEN WALL & CEILING
- PROVIDE 10MMX10MM SHADOW GAP BETWEEN WALL & FLOOR; SEE DETAILS
- PROVIDE ALUMINUM STRIPS FOR CHANGE OF FLOOR FINISH

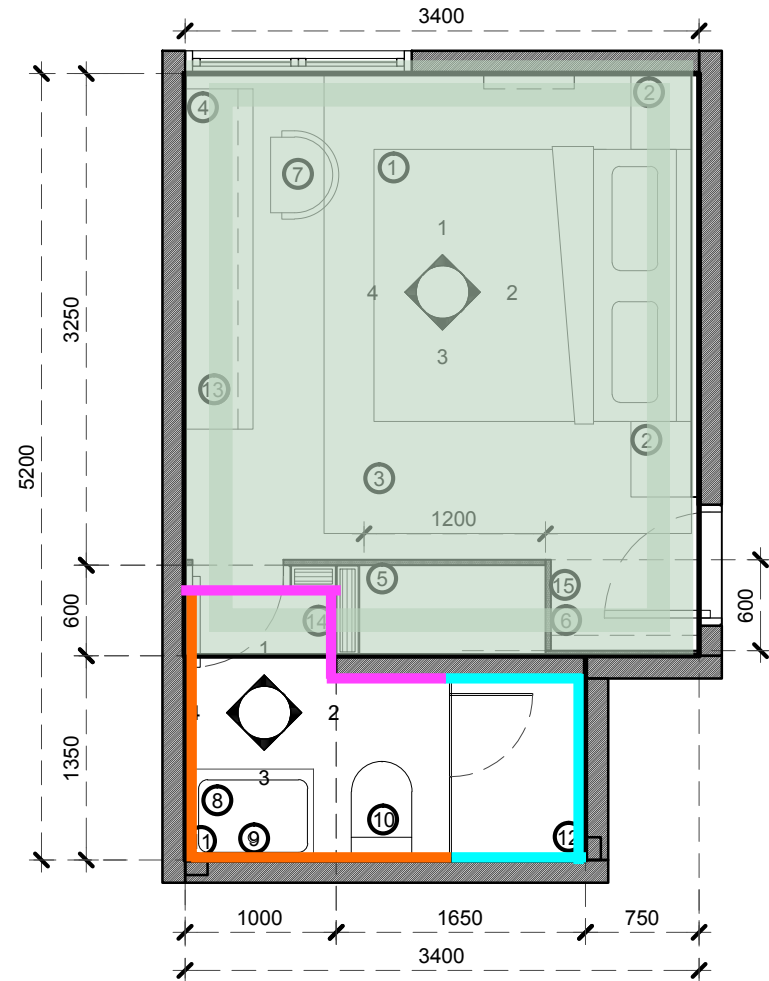

**1**  
 ID-1  
 MAJID'S BEDROOM + ENSUITE  
**FLOOR + FURNITURE LAYOUT**  
 SCALE  
 1: 50 MTS.

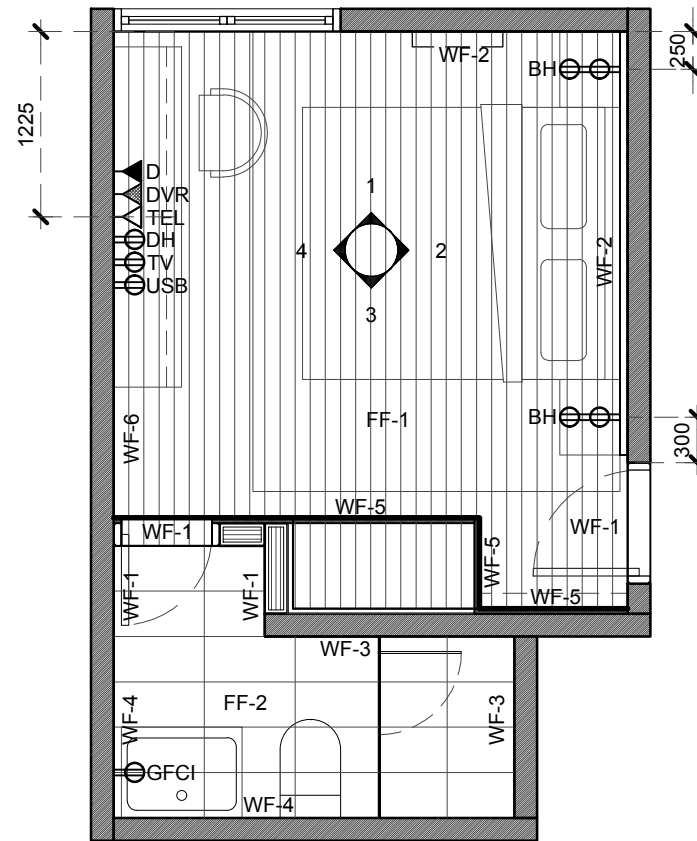

**2**  
 ID-1  
 MAJID'S BEDROOM + ENSUITE  
**FLOOR, WALL FINISH + POWER LAYOUT**  
 SCALE  
 1: 50 MTS.

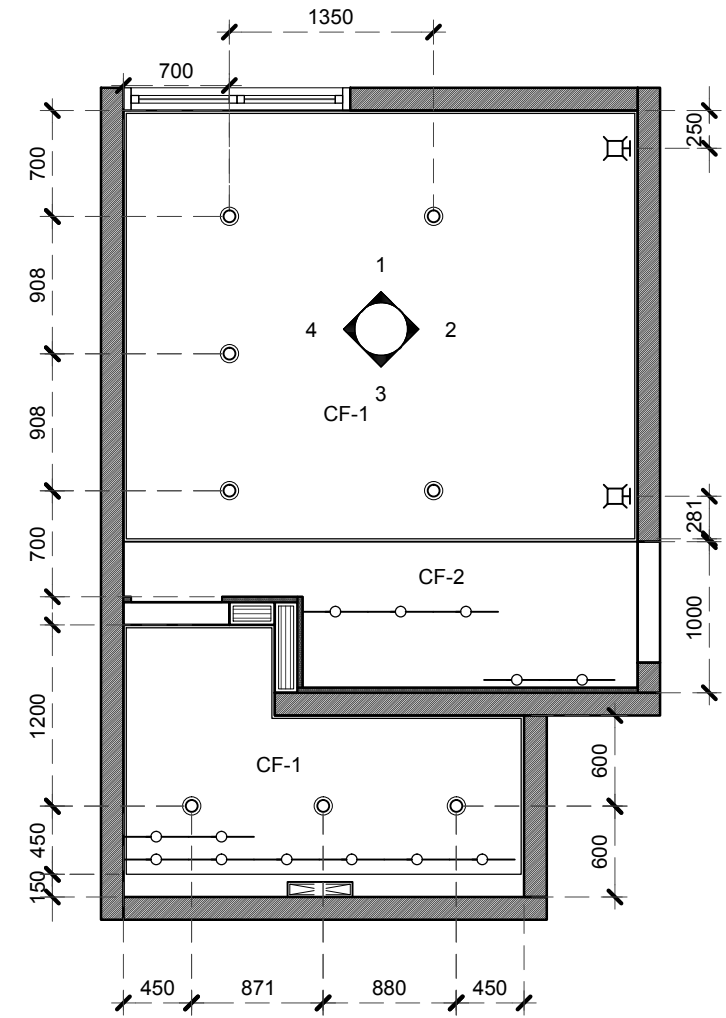

**2**  
 ID-1  
 MAJID'S BEDROOM + ENSUITE  
**REFLECTED CEILING LAYOUT**  
 SCALE  
 1: 50 MTS.

**LEGENDS**

①	KING SIZE BED WITH HEADBOARD	232 X223.5 X79CM	⑨	WALL MOUNT FAUCET	VERIFY ID	☼	WALL MOUNTED LIGHT (WARM WHITE)	CF-1	GYPSUM BD PAINTED FINISH; VERIFY ID
②	BEDSIDE TABLE	23.5 X 35H CM	⑩	CISTERNLESS WATERCLOSET	VERIFY ID	☼	LINEAR EXHAUST	CF-2	GYMBD PAINTED FIN 100 DROP; VERIFY ID
③	AREA RUG	243.8 X 304.8	⑩	BLACK WALL MOUNTED SHOWER	VERIFY ID	⊕	DUPLEX CONVENIENCE OUTLET (300MM)	WF-1	PAINTED SATIN FINISH; VERIFY COLOR
④	MEDIA CONSOLE WITH OFFICE DESK	225X60CM	⑪⑫	RECESSED BLACK NICHE	VERIFY ID	BH⊕	BED HEIGHT DCO (500MM)	WF-2	LIMEWASH PAINTED FINISH; VERIFY COLOR
⑤	OPEN HANGER AND CABINET	120X60CM	⑬	TABLE LAMP	VERIFY ID	DH⊕	DESK HEIGHT DCO (800MM)	WF-3	WALL TILES 30X60CM; VERIFY ID <b>45X90 CM</b>
⑥	FLOATING SHELVES	100X10CM	⑭⑮	ROBE OR COAT HOOK (BLACK)	VERIFY ID	GFCI⊕	GFCI CONVENIENCE OUTLET	WF-4	WALL TILES 30X90CM; VERIFY ID <b>30X90 CM</b>
⑦	ERGONOMIC OFFICE CHAIR - LEATHER	VERIFY ID	☉	DOWNLIGHT (WARM WHITE)		FF-1	ENGINEERED WOOD PLANKS; VERIFY ID	WF-5	15X15MM UPVC WALL PANEL; VERIFY ID
⑧	BUILT UP SINK ( CARRARA MARBLE)	VERIFY ID	—○—	ROPE LIGHT (WARM WHITE)		FF-2	FLOOR TILES 30X60CM; VERIFY ID	WF-6	WALLPAPER; VERIFY ID



**Arata Studio**  
 interiors | furniture | decor  
 Tordesillas, Makati, Metro Manila  
 hello@aratastudio.co | 09199997217 | 5222877


PROJECT TITLE: **MM RESIDENCE**  
 INTERIOR DESIGN  
 LOCATION: **UNIT 2G C BENITEZ TOWNHOMES, NEW MANILA, QUEZON CITY, PHILIPPINES**  
 NOTE: THIS DRAWING, AS AN INSTRUMENT OF SERVICE IS THE PROPERTY OF ARATA-K DESIGN STUDIO AND AS SUCH MUST NOT BE REPRODUCED OR COPIED IN PART OR IN WHOLE WITHOUT THE COMPANY'S PERMISSION. ALL DRAWINGS ARE TO BE RETURNED WHEN NO LONGER IN USE.

INTERIOR DESIGNER: **ARATA KOBAYASHI**  
 PTR NO. \_\_\_\_\_ REG. NO. \_\_\_\_\_  
 ISSUED ON \_\_\_\_\_  
 ISSUED AT \_\_\_\_\_  
 TIN \_\_\_\_\_

OWNER: **Mr. Majid Marohombsar**  
 SHEET CONTENTS: **AS SHOWN**  
 DATE: 1/2025 DRAWN BY: AI ENCODED BY: U CHECKED BY: AK SCALE: AS SHOWN


SHEET NO.  
**ID-1**

# TECHNO SPACE 45X90 CM

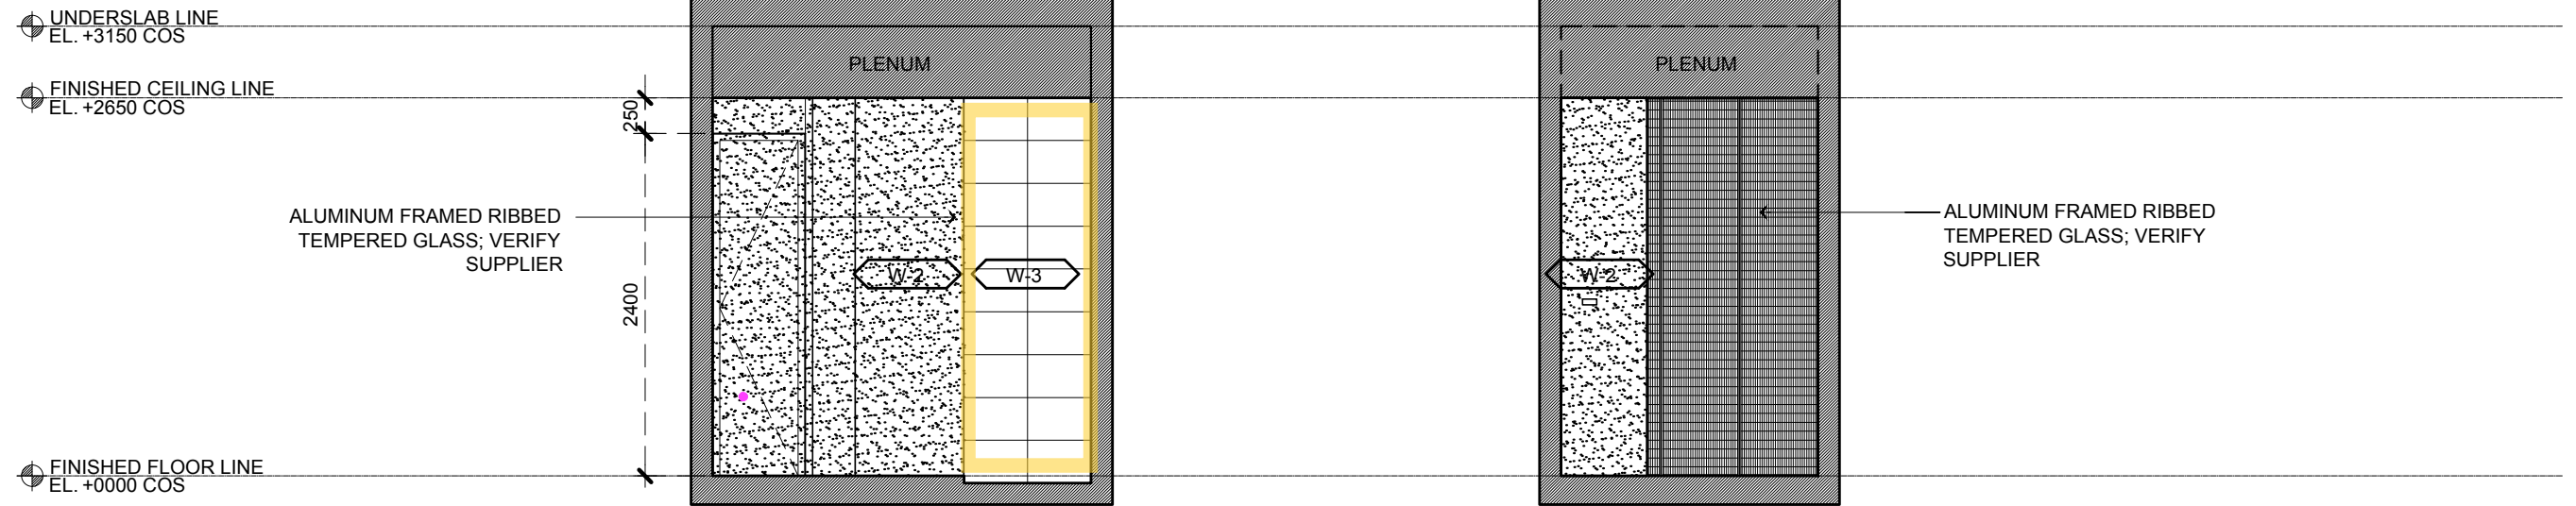


1  
D-3  
MAJID'S ENSUITE  
**WALL ELEVATION - 1**  
SCALE 1:50MTS

2  
D-3  
MAJID'S ENSUITE  
**WALL ELEVATION - 2**  
SCALE 1:50MTS

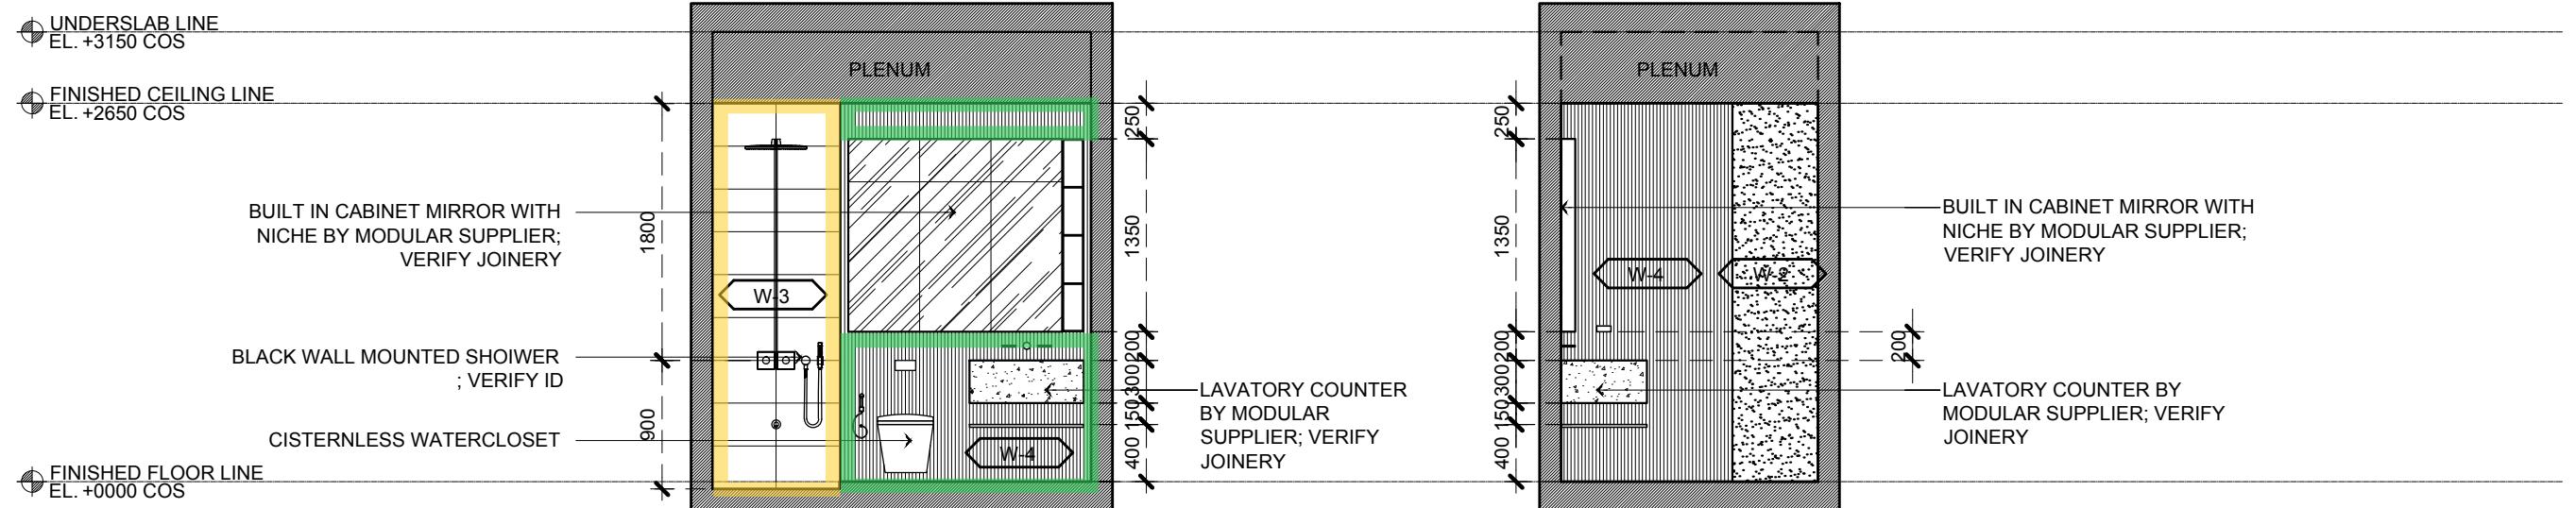

3  
D-3  
MAJID'S ENSUITE  
**WALL ELEVATION - 3**  
SCALE 1:50MTS

4  
D-3  
MAJID'S ENSUITE  
**WALL ELEVATION - 4**  
SCALE 1:50MTS

 <p><b>Arata Studio</b> interiors   furniture   decor Tordesillas, Makati, Metro Manila hello@aratastudio.co   09199997217   5222877</p>	<p>PROJECT TITLE: <b>MM RESIDENCE INTERIOR DESIGN</b></p>	<p>INTERIOR DESIGNER: <b>ARATA KOBAYASHI</b></p>	<p>OWNER: <b>Mr. Majid Marohombsar</b></p>	<p>SHEET NO. <b>ID-3</b></p>
	<p>LOCATION: <b>UNIT 2G C BENITEZ TOWNHOMES, NEW MANILA, QUEZON CITY, PHILIPPINES</b></p>	<p>PTR NO. _____ REG. NO. _____</p> <p>ISSUED ON _____</p> <p>ISSUED AT _____</p> <p>TIN _____</p>	<p>SHEET CONTENTS: <b>AS SHOWN</b></p>	<p>DATE: 1/2025 DRAWN BY: AI ENCODED BY: U CHECKED BY: AK SCALE: AS SHOWN</p>

NOTE: THIS DRAWING, AS AN INSTRUMENT OF SERVICE IS THE PROPERTY OF ARATA-K DESIGN STUDIO AND AS SUCH MUST NOT BE REPRODUCED OR COPIED IN PART OR IN WHOLE WITHOUT THE COMPANY'S PERMISSION. ALL DRAWINGS ARE TO BE RETURNED WHEN NO LONGER IN USE.